

PROJECT SUMMARY

THIS PROJECT ENCOMPASSES THE INSTALLATION OF A NEW 20' TALL X 26' DIAMETER WATER STORAGE TANK TO SERVICE A FIRE PUMP AND AUTOMATIC FIRE SPRINKLER SYSTEM.

INLAND FIRE PROTECTION, INC.
Automatic Fire Sprinkler System
1100 AHTANUM RD
YAKIMA, WA 98903
509-248-4471

3028 GS CENTER RD
WENATCHEE, WA 98807
509-884-6717

LIC # INLANFP161ML

COPYRIGHT RESERVED. ALL PARTS OF THIS DRAWING ARE THE EXCLUSIVE PROPERTY OF INLAND FIRE PROTECTION, INC. THE DRAWING SHALL NOT BE PRODUCED IN ANY WAY WITHOUT THE EXPRESSED WRITTEN PERMISSION OF INLAND FIRE PROTECTION, INC.

FIELD INSPECTION BY
Kittitas County Building Dept.

WATER DEPARTMENT
[jobsite]



ARCHITECT/DESIGN
PROFESSIONAL

PROJECT
Al Dahra Water Storage Tank
5693 Vantage Highway
Ellensburg, WA 98926
Parcel ID 854934

CONTRACTOR
Al Dahra ACX
5693 Vantage Highway
Ellensburg, WA 98926
Aldo De La Rosa
1(562)755-5805


DRAWN BY
Ryan

DATE: Apr26
JOB NUMBER
1

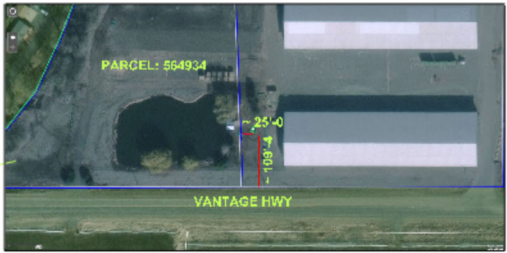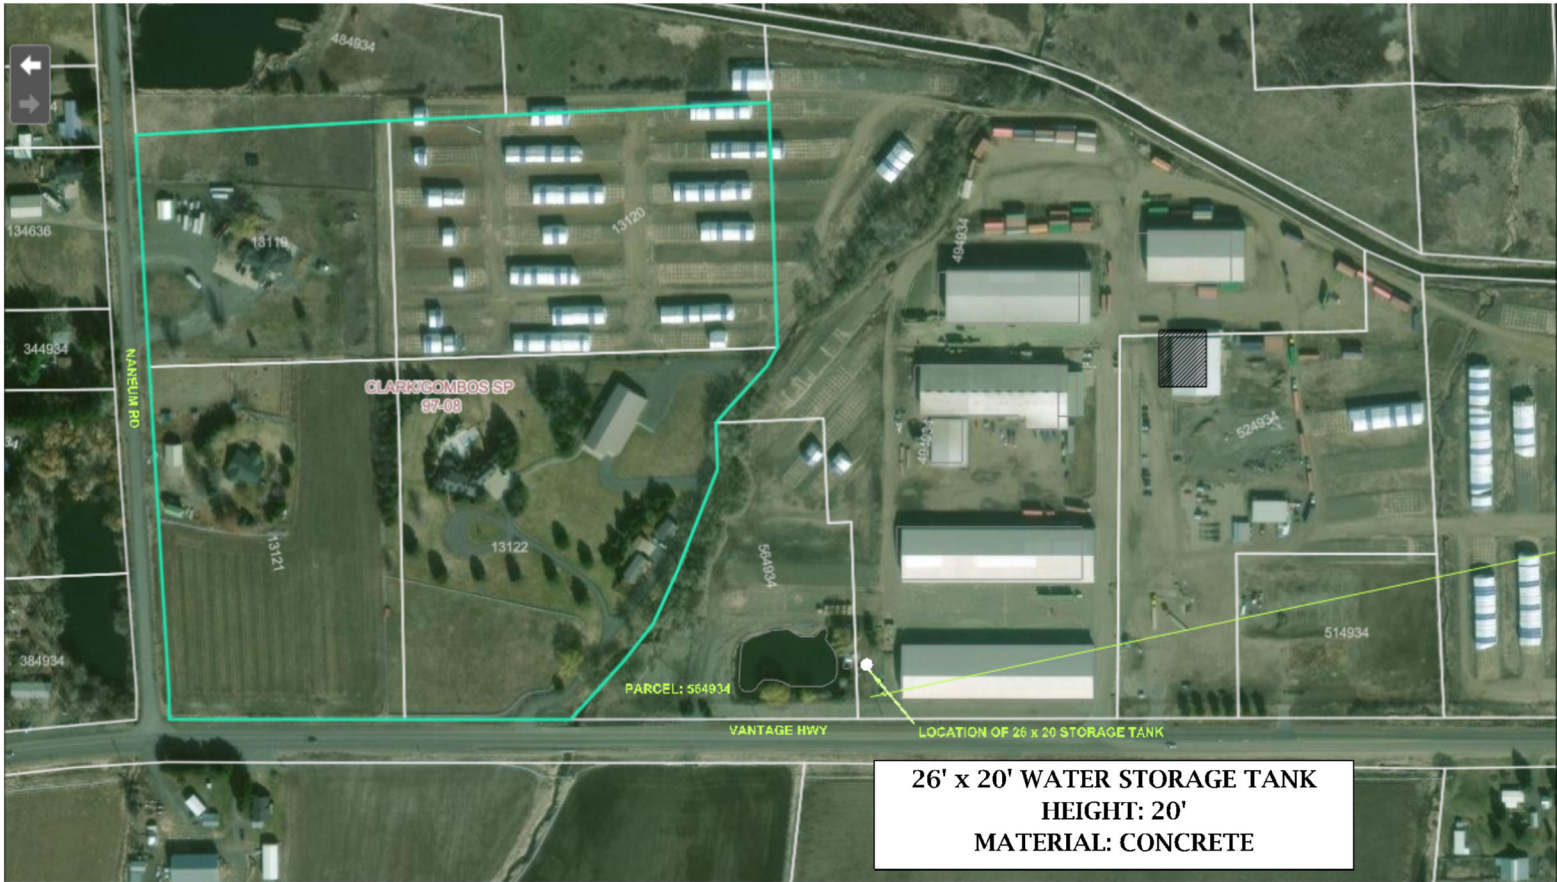

SITE PLAN

1" = 400'-0"

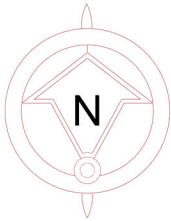

KITTITAS CO CDS
RECEIVED
04/13/2026

